



Scale Bar



FIT MARK A

FIT MARK B


SEC C

SEC B

SEC A

SEC B

SEC A

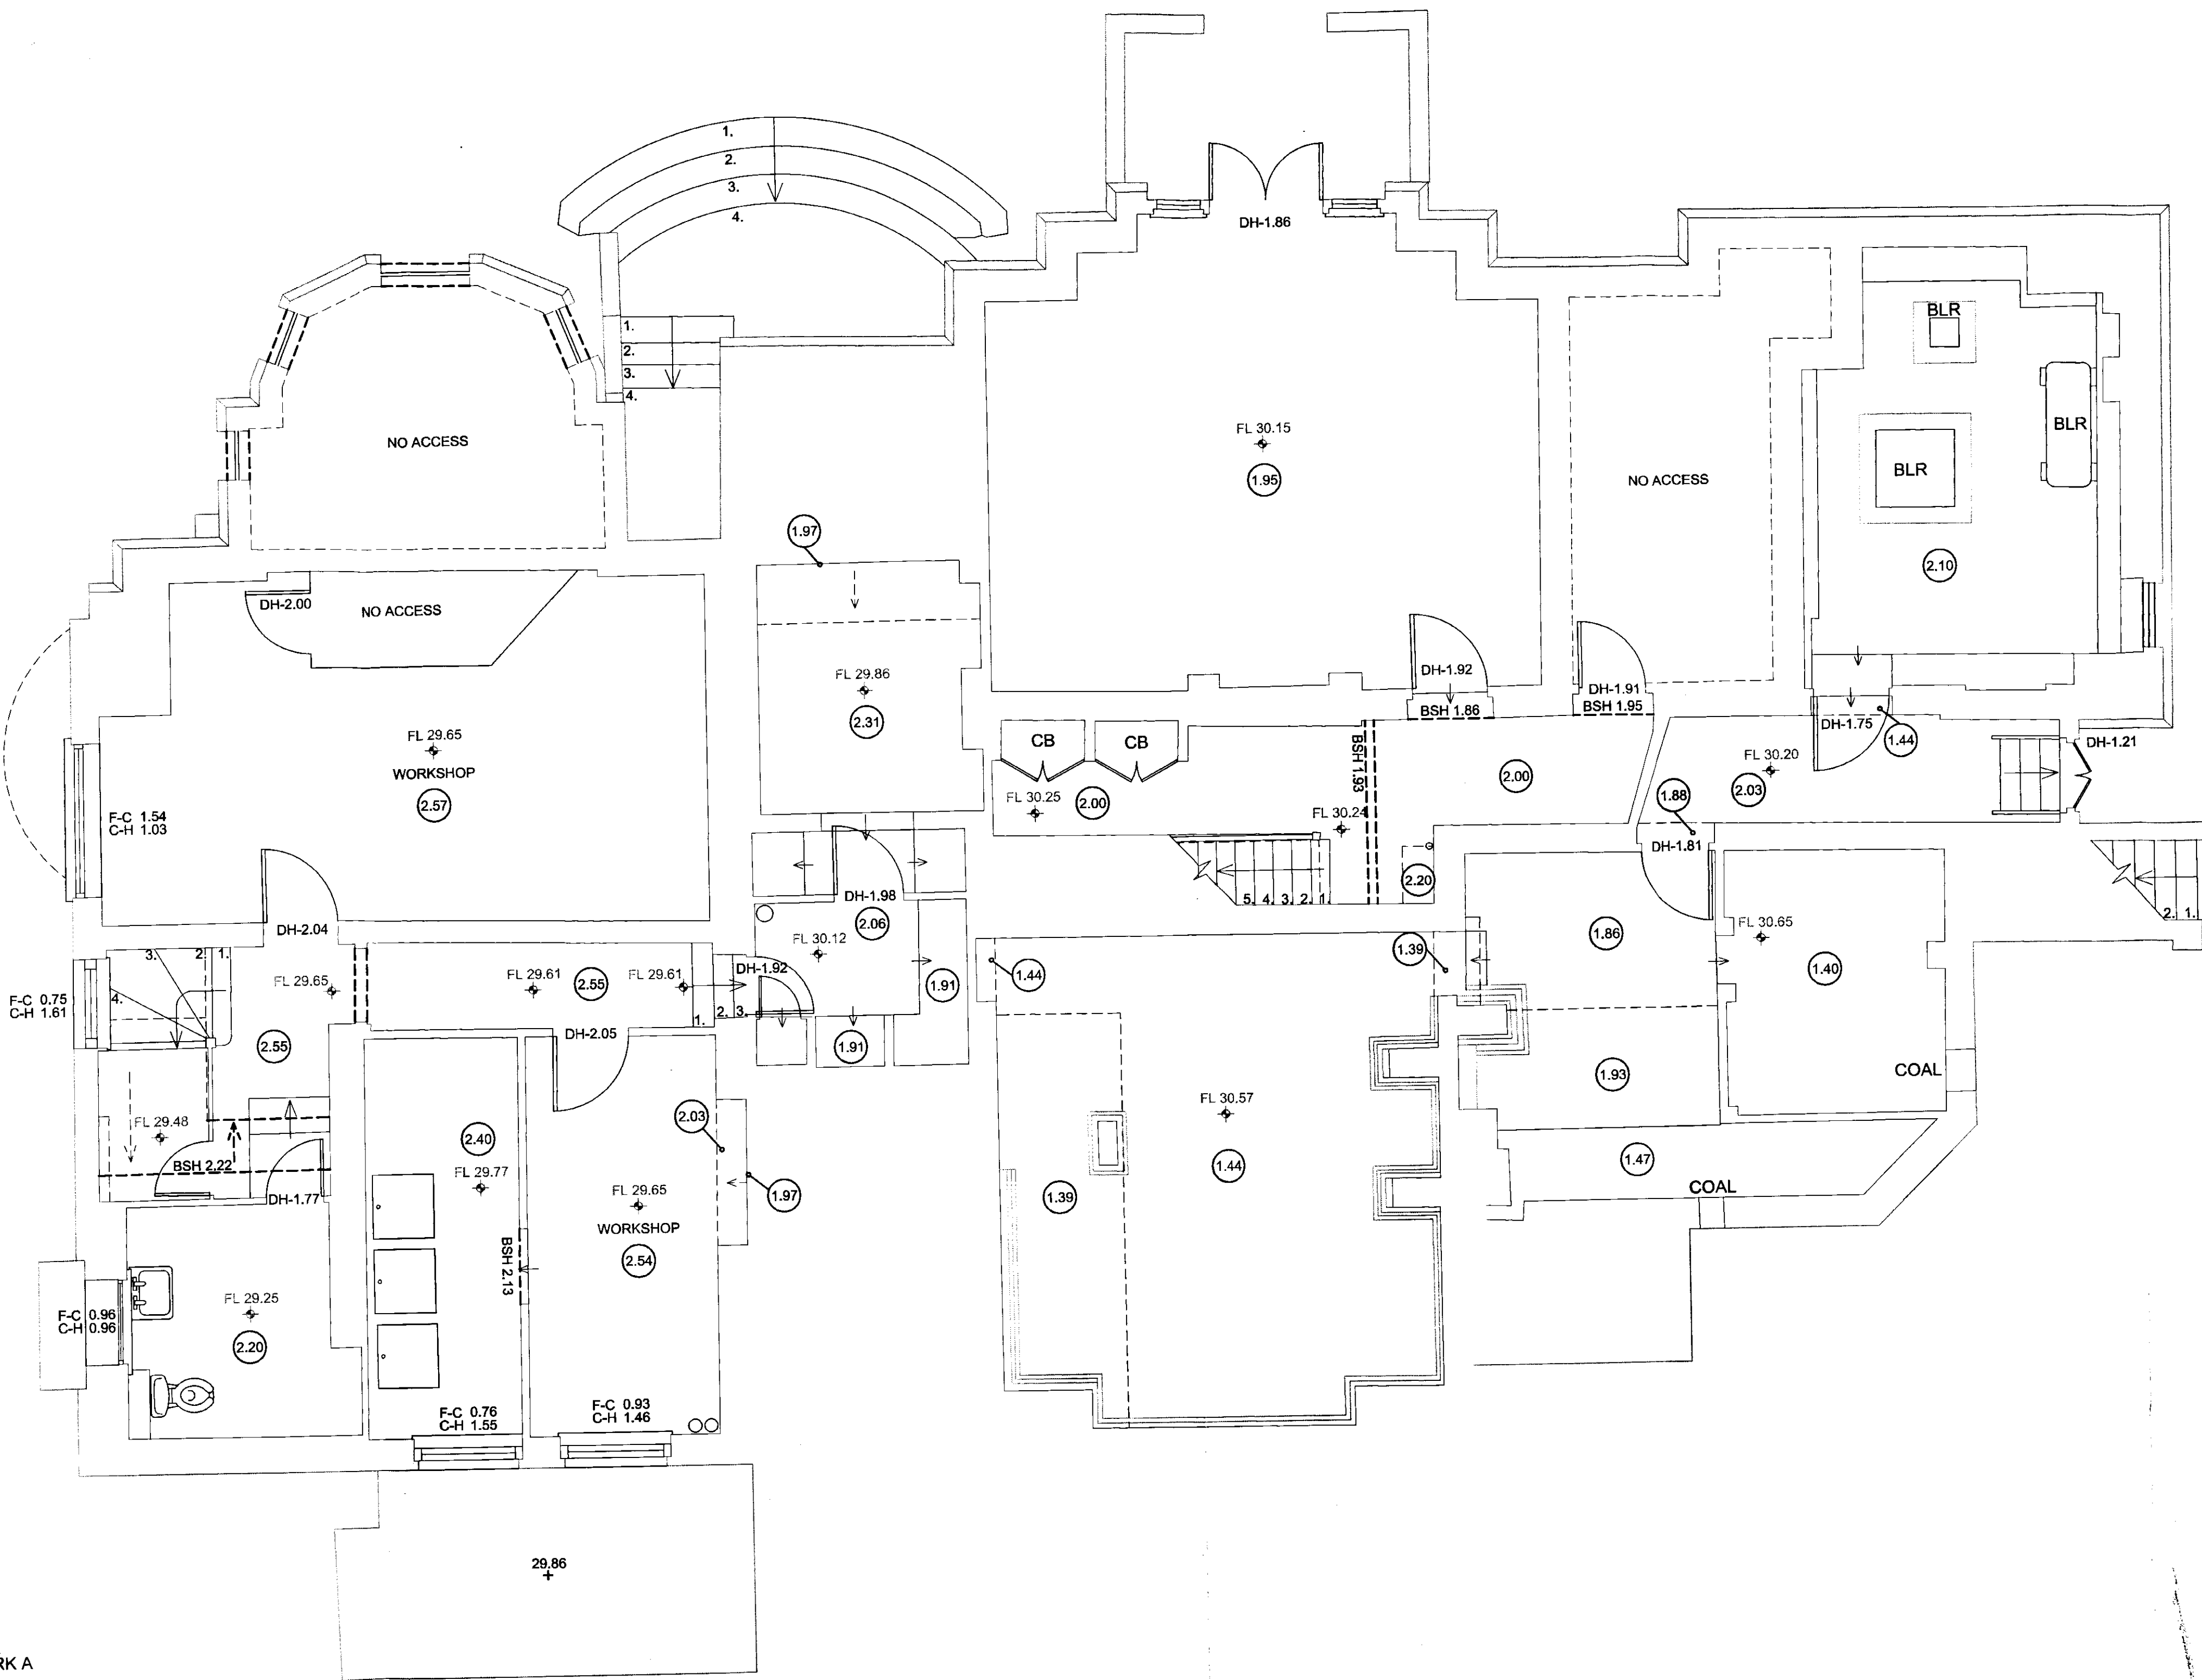


DO NOT SCALE FROM DRAWING
ALL DIMENSIONS TO BE CHECKED ON SITE

METRO PLANS	
BUILDING SURVEY	
LEGEND	
F-C 0.00	FLOOR TO CILL HEIGHT
C-H 0.00	CILL TO HEAD HEIGHT
FL 21.80	FLOOR TO CEILING HEIGHT
0.00	FLOOR LEVEL
0.00	SPRING HEIGHT
0.00	SINGLE STEP HEIGHT
0.00	ACCESS HATCH
0.00	ARCH HEAD LEVEL
0.00	BOILER
0.00	BOLLARD
0.00	BENCHMARK
0.00	BEAM SOFFIT LEVEL
0.00	CABINET
0.00	CABLE TV
0.00	CUPBOARD
0.00	CCTV CAMERA
0.00	CEILING LEVEL
0.00	COUNTER
0.00	CEILING HATCH
0.00	CEILING LIGHT
0.00	CEILING VENT
0.00	DOOR HEIGHT
0.00	DOUBLE SOCKET
0.00	EAVE LEVEL
0.00	ELECTRIC METER
0.00	ELECTRICAL POLE
0.00	FALSE CEILING
0.00	FIRE PLACE
0.00	FUSE BOARD
0.00	FIRE ALARM
0.00	FIRE INDICATOR
0.00	FIRE EXTINGUISHER
0.00	GAS METER
0.00	GATE POST
0.00	GAS VALVE
0.00	GULLY
0.00	INSPECTION CHAMBER
0.00	STORM WATER INLET
0.00	LAMP POST
0.00	MANHOLE
0.00	COVER LEVEL
0.00	INVERT LEVEL
0.00	OVER HEAD CABLE
0.00	OVERHANG
0.00	POLE
0.00	PARAPET LEVEL
0.00	POST & TELECOM
0.00	POWER SUPPLY
0.00	RADIATOR
0.00	RODDING EYE
0.00	ROAD SIGN
0.00	RAIN WATER PIPE
0.00	RIDGE LEVEL
0.00	SKYLIGHT
0.00	STOP VALVE
0.00	SOIL VENT PIPE
0.00	SINGLE SOCKET
0.00	SWITCH
0.00	TOP OF FENCE
0.00	TOP OF WALL
0.00	TELEPHONE POLE
0.00	UP LIGHTER
0.00	WATER HEATER
0.00	WATER MAIN
0.00	WATER TANK
0.00	WATER VALVE
0.00	WALL LAMP
0.00	TREE DECIDUOUS
0.00	TREE CONIFEROUS
0.00	BUSH

NOTES

All Levels to OS benchmark.
All door numbers relate to Camelot nos.

-	-	-	-
-	-	-	-
-	-	-	-
-	FULL ISSUE	07/10/2008	BB
-	PRELIMINARY	06/10/2008	BB

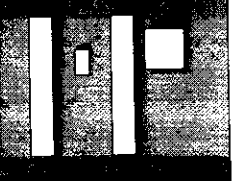

METRO PLANS
3 GALENA RD
HAMMERSMITH
LONDON W6 0LT
TEL NO. + 44 (0) 20 8741 4699
FAX NO. + 44 (0) 20 8741 6442
EMAIL: info@metroplans.com
WEB: www.metroplans.com

LAND & MEASURED BUILDING SURVEYS

CASE FILE COPY

DATE RECEIVED: 08 APR 2011

REGISTERED NUMBER: 10111111

SOUTHAMPTON COUNCIL

PLANNING




SECTION AND DATE

CLIENT	CITRUS GROUP		
PROJECT	No.123 GROVE PK		
SURVEY TYPE	FLOOR PLANS		
Drawn by	JG	Scale	1:50
Checked by	BB	Job No.	2538
Date	OCT 2008	Dwg No.	2538-01


No.123 GROVE PARK
LOWER GROUND FLOOR PLAN

0 1000 2000 3000 4000
Millimeters (mm)

Scale Bar

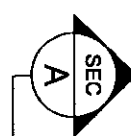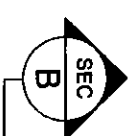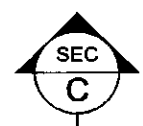

FIT MARK B

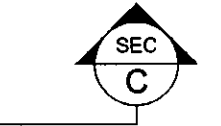

FIT MARK A

No.123 GROVE PARK
GROUND FLOOR PLAN

DO NOT SCALE FROM DRAWING
ALL DIMENSIONS TO BE CHECKED ON SITE

METRO PLANS	
BUILDING SURVEY	
LEGEND	
F-C 0.00	FLOOR TO CILL HEIGHT
C-H 0.00	CILL TO HEAD HEIGHT
FL 21.80	FLOOR TO CEILING HEIGHT
FL 21.80	FLOOR LEVEL
0.00sp	SPRING HEIGHT
AS	SINGLE STEP HEIGHT
AH	ACCESS HATCH
AHL	ARCH HEAD LEVEL
BLR	BOILER
BOL	BOLLARD
BM	BENCHMARK
BSL	BEAM SOFFIT LEVEL
CAB	CABINET
CATV	CABLE TV
CBD	CUPBOARD
CCTV	CCTV CAMERA
CL	CEILING LEVEL
CNT	COUNTER
CH	CEILING HATCH
CL	CEILING LIGHT
CV	CEILING VENT
DH	DOOR HEIGHT
DS	DOUBLE SOCKET
EAVE-00.00	EAVE LEVEL
EM	ELECTRIC METER
EP	ELECTRIC POLE
FC	FALSE CEILING
FP	FIRE PLACE
FB	FUSE BOARD
FA	FIRE ALARM
FI	FIRE INDICATOR
FE	FIRE EXTINGUISHER
GM	GAS METER
GP	GATE POST
GV	GAS VALVE
GY	GULLY
IC	INSPECTION CHAMBER
KI	STORM WATER INLET
LP	LAMP POST
MH	MANHOLE
-CL-	COVER LEVEL
-IL-	INVERT LEVEL
OHC	OVER HEAD CABLE
OHC	OVERHANG
P	POLE
PAR-00.00	PARAPET LEVEL
P&T	POST & TELECOM
PS	POWER SUPPLY
RAD	RADIATOR
RE	RODDING EYE
RS	ROAD SIGN
RWP	RAIN WATER PIPE
RIDGE-00.00	RIDGE LEVEL
SLV	SHELVING
SL	SKYLIGHT
SV	STOP VALVE
SVP	SOIL VENT PIPE
SS	SINGLE SOCKET
SW	SWITCH
ToF-00.00	TOP OF FENCE
ToW-00.00	TOP OF WALL
TP	TELEPHONE POLE
UPL	UP LIGHTER
WH	WATER HEATER
WM	WATER MAIN
WT	WATER TANK
WV	WATER VALVE
WL	WALL LAMP
(Tree Symbol)	TREE DECIDUOUS
(Tree Symbol)	TREE CONIFEROUS
(Bush Symbol)	BUSH

NOTES

All Levels to OS benchmark.
All door numbers relate to Camelot nos.

-	-	-	-
-	-	-	-
-	-	-	-
-	-	-	-
-	FULL ISSUE	07/10/2008	BB
-	PRELIMINARY	06/10/2008	BB



METRO PLANS
3 GALENA RD
HAMMERSMITH
LONDON W6 0LT
TEL NO. + 44 (0) 20 8741 4899
FAX NO. + 44 (0) 2087416442
EMAIL: info@metroplans.com
WEB: www.metroplans.com


LAND & MEASURED BUILDING SURVEYS

CLIENT	CITRUS GROUP		
PROJECT	No.123 GROVE PK		
SURVEY TYPE	FLOOR PLANS		
Drawn by	JG	Scale	1:50
Checked by	BB	Job No.	2538
Date	OCT 2008	Dwg No.	2538-02


SOUTHAMPTON COUNCIL PLANNING
CASE FILE COPY
DATE RECEIVED 08 APR 2011
REGISTERED NUMBER 1101123



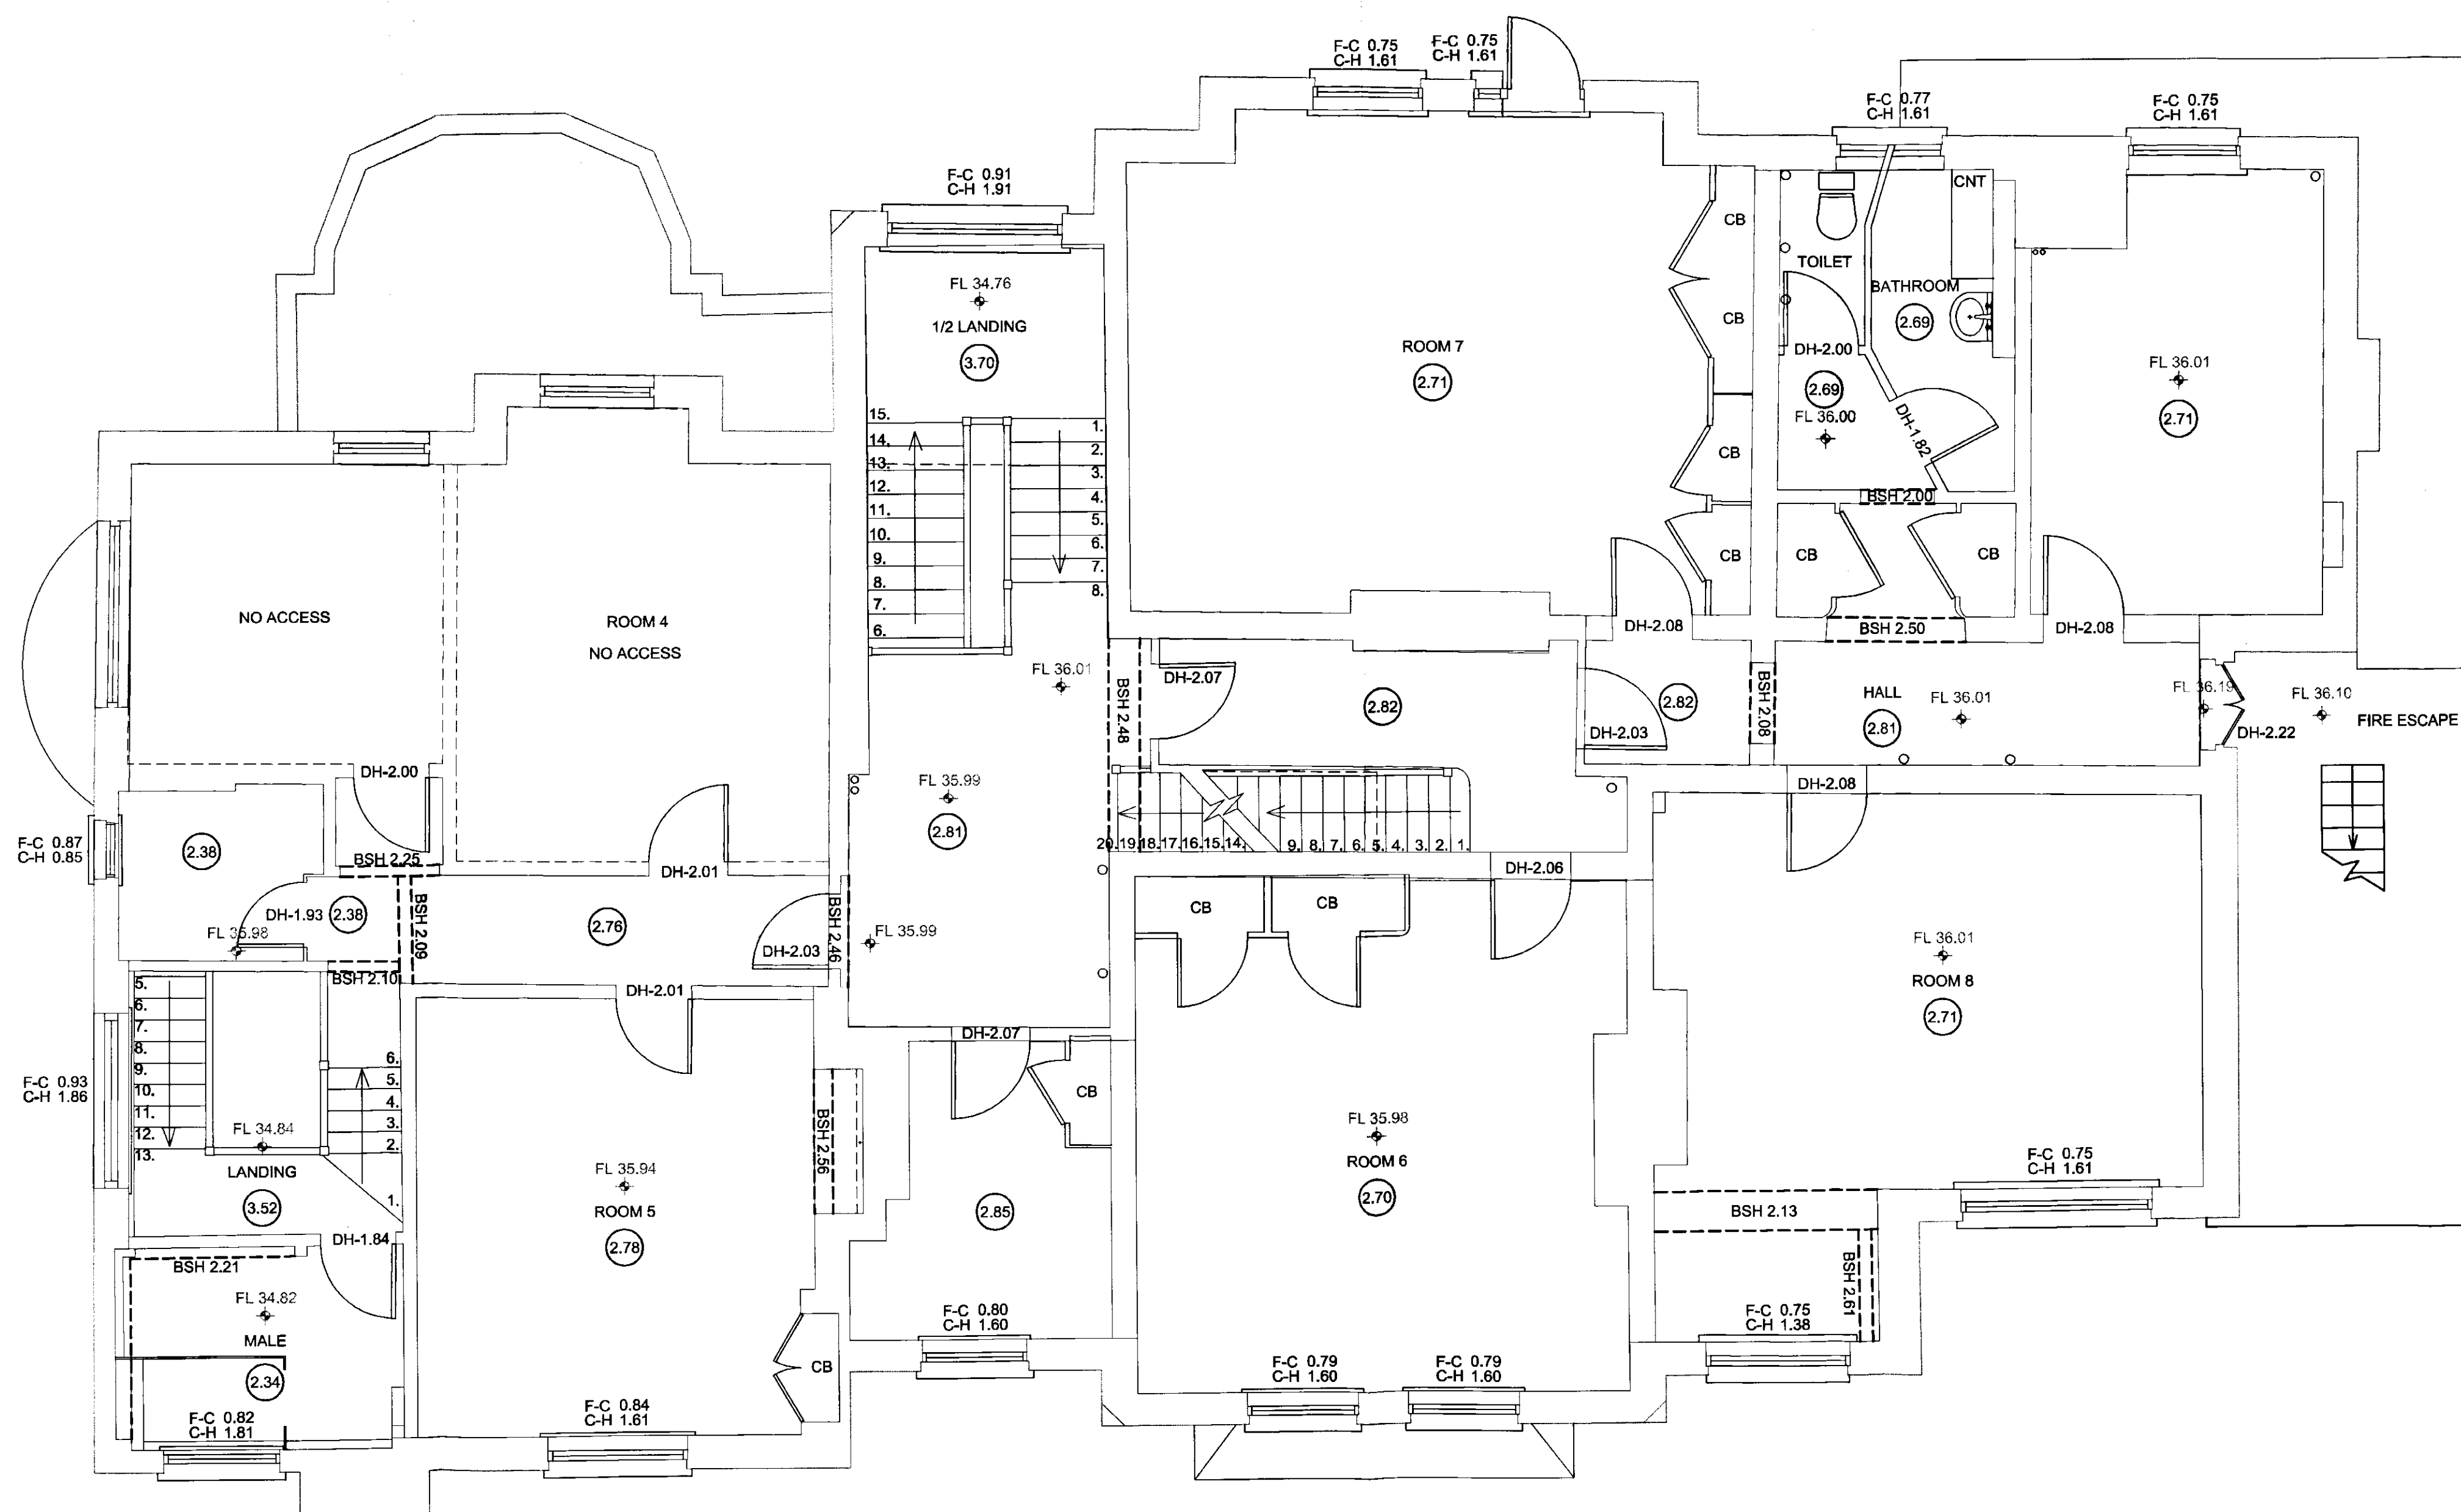


No.123 GROVE PARK
1st FLOOR PLAN



FIT MARK B



DO NOT SCALE FROM DRAWING ALL DIMENSIONS TO BE CHECKED ON SITE	
METRO PLANS	
BUILDING SURVEY	
LEGEND	
F-C 0.00	FLOOR TO CILL HEIGHT
C-H 0.00	CILL TO HEAD HEIGHT
FL 2.10	FLOOR LEVEL
C 0.00	CEILING HEIGHT
1	SINGLE STEP HEIGHT
AH	ACCESS HATCH
ARH	ARCH HEAD LEVEL
BLR	BOILER
BM	BOLLARD
BSL	BENCHMARK
BSL	BEAM SOFFIT LEVEL
CAB	CABINET
CATV	CABLE TV
CB	CEILING BOARD
CCTV	CCTV CAMERA
CL	CEILING LEVEL
CNT	COUNTER
CH	CEILING HATCH
CL	CEILING LIGHT
CV	CEILING VENT
DM	DOOR HEIGHT
DS	DOUBLE SOCKET
EMV	ELECTRIC METER
EP	ELECTRICAL POLE
FC	FALSE CEILING
FP	FIRE PLACE
FB	FUSE BOARD
FA	FIRE ALARM
FI	FIRE INDICATOR
FE	FIRE EXTINGUISHER
GM	GAS METER
GP	GATE POST
GS	GAS VALVE
GV	GULLY
IC	INSPECTION CHAMBER
CSB	STORM WATER INLET
LP	LAMP POST
NH	MANHOLE
—CL—	COVER LEVEL
—	INVERT LEVEL
OHC	OVER HEAD CABLE
OHG	OVERHANG
	POLE
PAR:00.00	PARAPET LEVEL
P&T	POST & TELECOM
PS	POWER SUPPLY
RAD	RADIATOR
RE	ROOFTOP EYE
RS	ROAD SIGN
RWP	RAIN WATER PIPE
RIDGE:00.00	RIDGE LEVEL
SLV	SHELVING
SL	SKYLIGHT
SV	SOFT VALVE
SOV	SOIL VENT PIPE
SS	SINGLE SOCKET
SW	SWITCH
TF:00.00	TOP OF FENCE
TW:00.00	TOP OF WALL
TP	TELEPHONE POLE
UPL	UP LIGHTER
WH	WATER HEATER
WM	WATER MAIN
WT	WATER TANK
WV	WATER VALVE
WL	WALL LAMP
	TREE DECIDUOUS
	TREE CONIFEROUS
	BUSH

NOTES

All Levels to OS benchmark.
All door numbers relate to Camelot nos.

-	-	-	-
-	-	-	-
-	-	-	-
-	FULL ISSUE	07/10/2008	BB
-	PRELIMINARY	06/10/2008	BB



CLIENT CITRUS GROUP


PROJECT No.123 GROVE PK

SURVEY TYPE	FLOOR PLANS
-------------	-------------

Drawn by	JG	Scale	1:50
Checked by	BB	Job No.	2538
Date	OCT 2008	Dwg No.	2538-03

0 1000 2000 3000 4000
Millimeters (mm)

Scale Bar

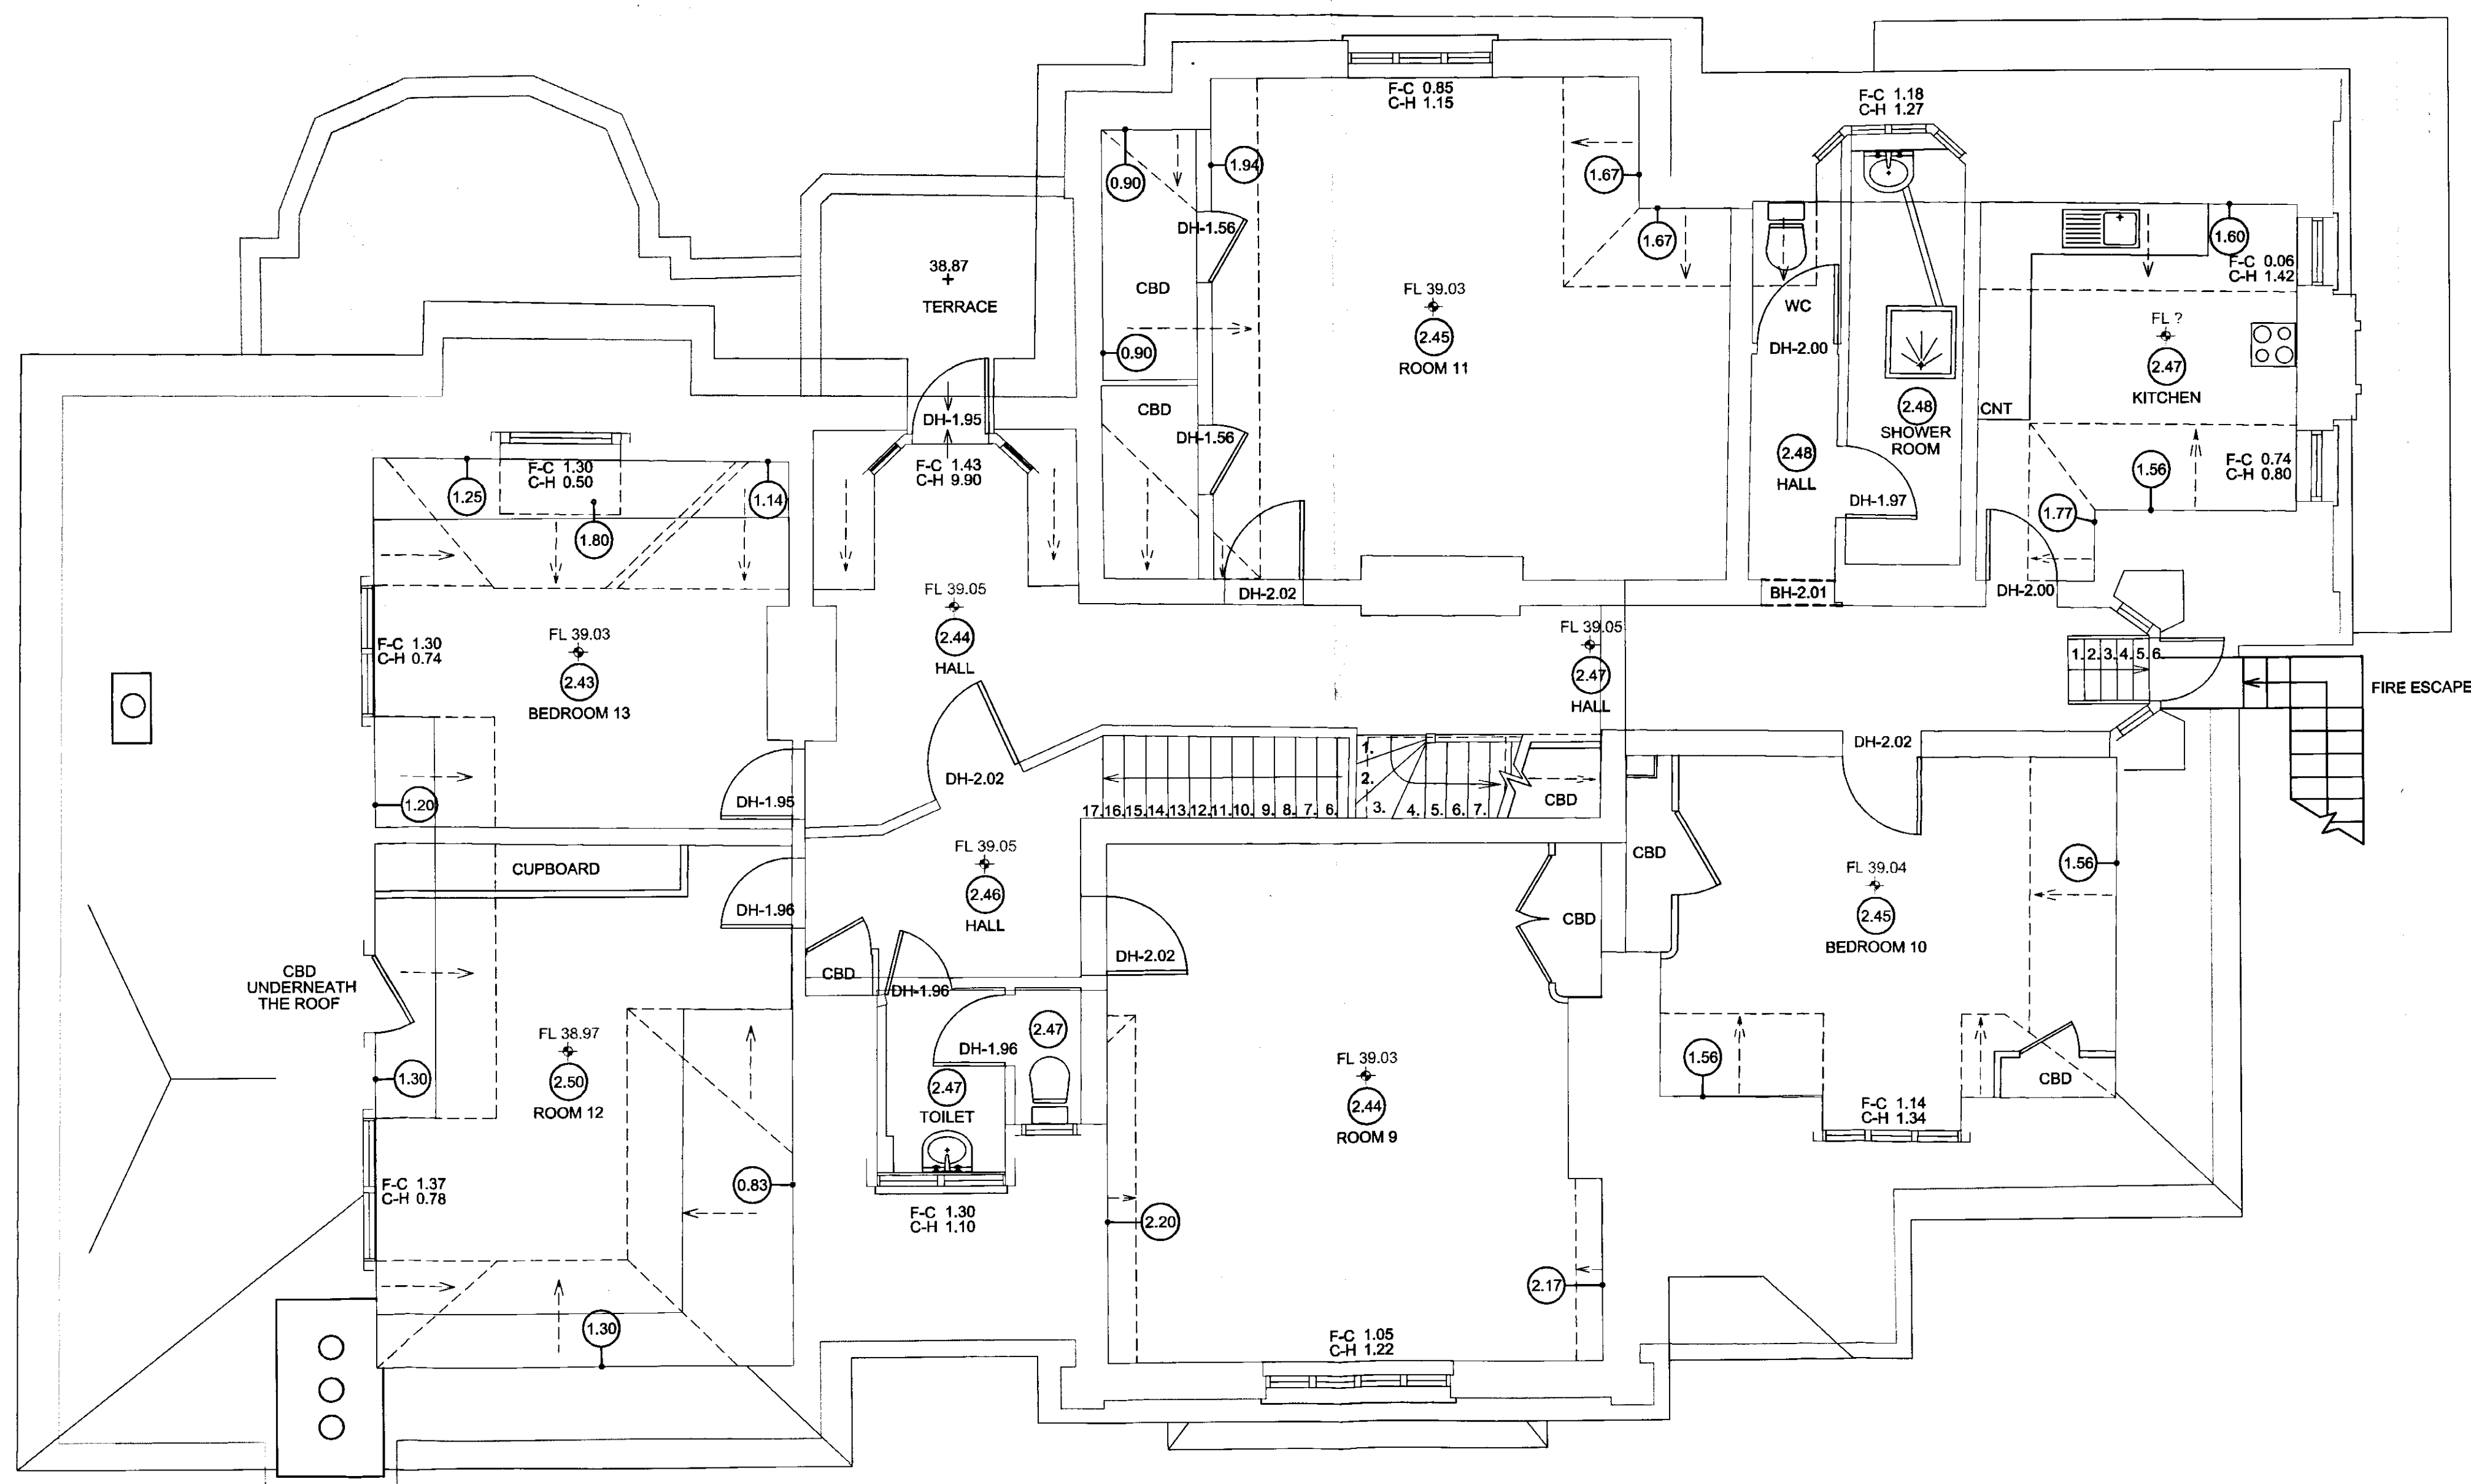

FIT MARK B

SEC C

SEC C

FIT MARK A

No.123 GROVE PARK
2nd FLOOR PLAN


DO NOT SCALE FROM DRAWING
ALL DIMENSIONS TO BE CHECKED ON SITE

METRO PLANS BUILDING SURVEY	
LEGEND	
F-C 0.00	FLOOR TO CILL HEIGHT
C-H 0.00	CILL TO HEAD HEIGHT
FL 21.80	FLOOR TO CEILING HEIGHT
FL 21.80	FLOOR LEVEL
0.00sp	SPRING HEIGHT
0.00	SINGLE STEP HEIGHT
AH	ACCESS HATCH
AHL	ARCH HEAD LEVEL
BLR	BOILER
BOL	BOLLARD
BM 76	BENCHMARK
BSL	BEAM SOFFIT LEVEL
CAB	CABINET
CATV	CABLE TV
CBD	CUPBOARD
CCTV	CCTV CAMERA
CL	CEILING LEVEL
CNT	COUNTER
CH	CEILING HATCH
CL	CEILING LIGHT
CV	CEILING VENT
DH	DOOR HEIGHT
DS	DOUBLE SOCKET
EAVE:00.00	EAVE LEVEL
EM	ELECTRIC METER
EP	ELECTRICAL POLE
FC	FALSE CEILING
FP	FIRE PLACE
FB	FUSE BOARD
FA	FIRE ALARM
FI	FIRE INDICATOR
FE	FIRE EXTINGUISHER
GM	GAS METER
GP	GATE POST
GV	GAS VALVE
GULLY	GULLY
IC	INSPECTION CHAMBER
KI	STORM WATER INLET
LP	LAMP POST
MH	MANHOLE
-CL-	COVER LEVEL
-IL-	INVERT LEVEL
OHC	OVER HEAD CABLE
OHG	OVERHANG
P	POLE
PAR:00.00	PARAPET LEVEL
P&T	POST & TELECOM
PS	POWER SUPPLY
RAD	RADIATOR
RE	RODDING EYE
RS	ROAD SIGN
RWP	RAIN WATER PIPE
RIDGE:00.00	RIDGE LEVEL
SLV	SHELVING
SL	SKYLIGHT
SV	STOP VALVE
SVP	SOIL VENT PIPE
SS	SINGLE SOCKET
SW	SWITCH
TOP:00.00	TOP OF FENCE
TOW:00.00	TOP OF WALL
TP	TELEPHONE POLE
ULP	UP LIGHTER
WH	WATER HEATER
WM	WATER MAIN
WT	WATER TANK
WV	WATER VALVE
WL	WALL LAMP
Tree Deciduous	TREE DECIDUOUS
Tree Coniferous	TREE CONIFEROUS
Bush	BUSH

NOTES

All Levels to OS benchmark.
All door numbers relate to Camelot nos.


-	-	-	-
-	-	-	-
-	-	-	-
-	FULL ISSUE	07/10/2008	BB
-	PRELIMINARY	06/10/2008	BB

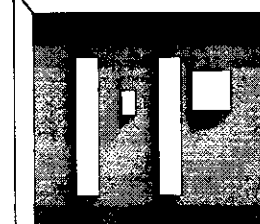

METRO PLANS

3 GALENA RD
HAMMERSMITH
LONDON W6 0LT
TEL NO. + 44 (0) 20 8741 4699
FAX NO. + 44 (0) 20 8741 4642
EMAIL: info@metroplans.com
WEB: www.metroplans.com



LAND & MEASURED BUILDING SURVEYS

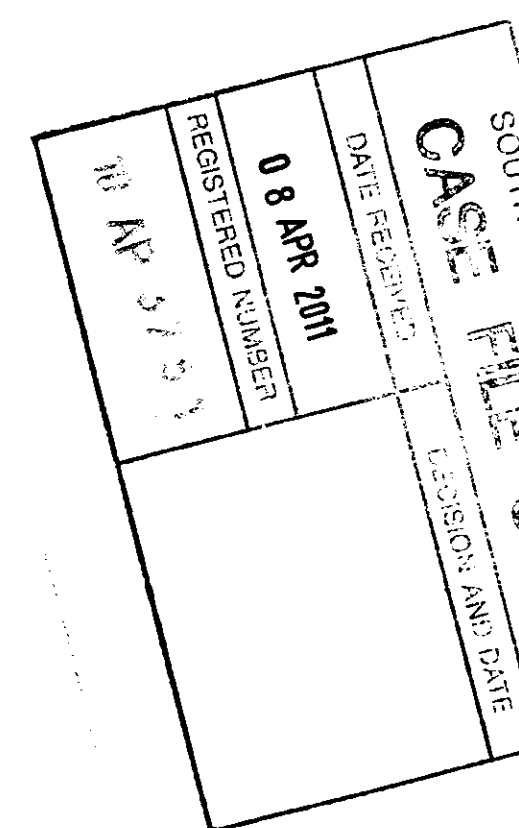

CLIENT	CITRUS GROUP		
PROJECT	No.123 GROVE PK		
SURVEY TYPE	FLOOR PLANS		
Drawn by	JG	Scale	1:50
Checked by	BB	Job No.	2538
Date	OCT 2008	Dwg No.	2538-04



Scale Bar

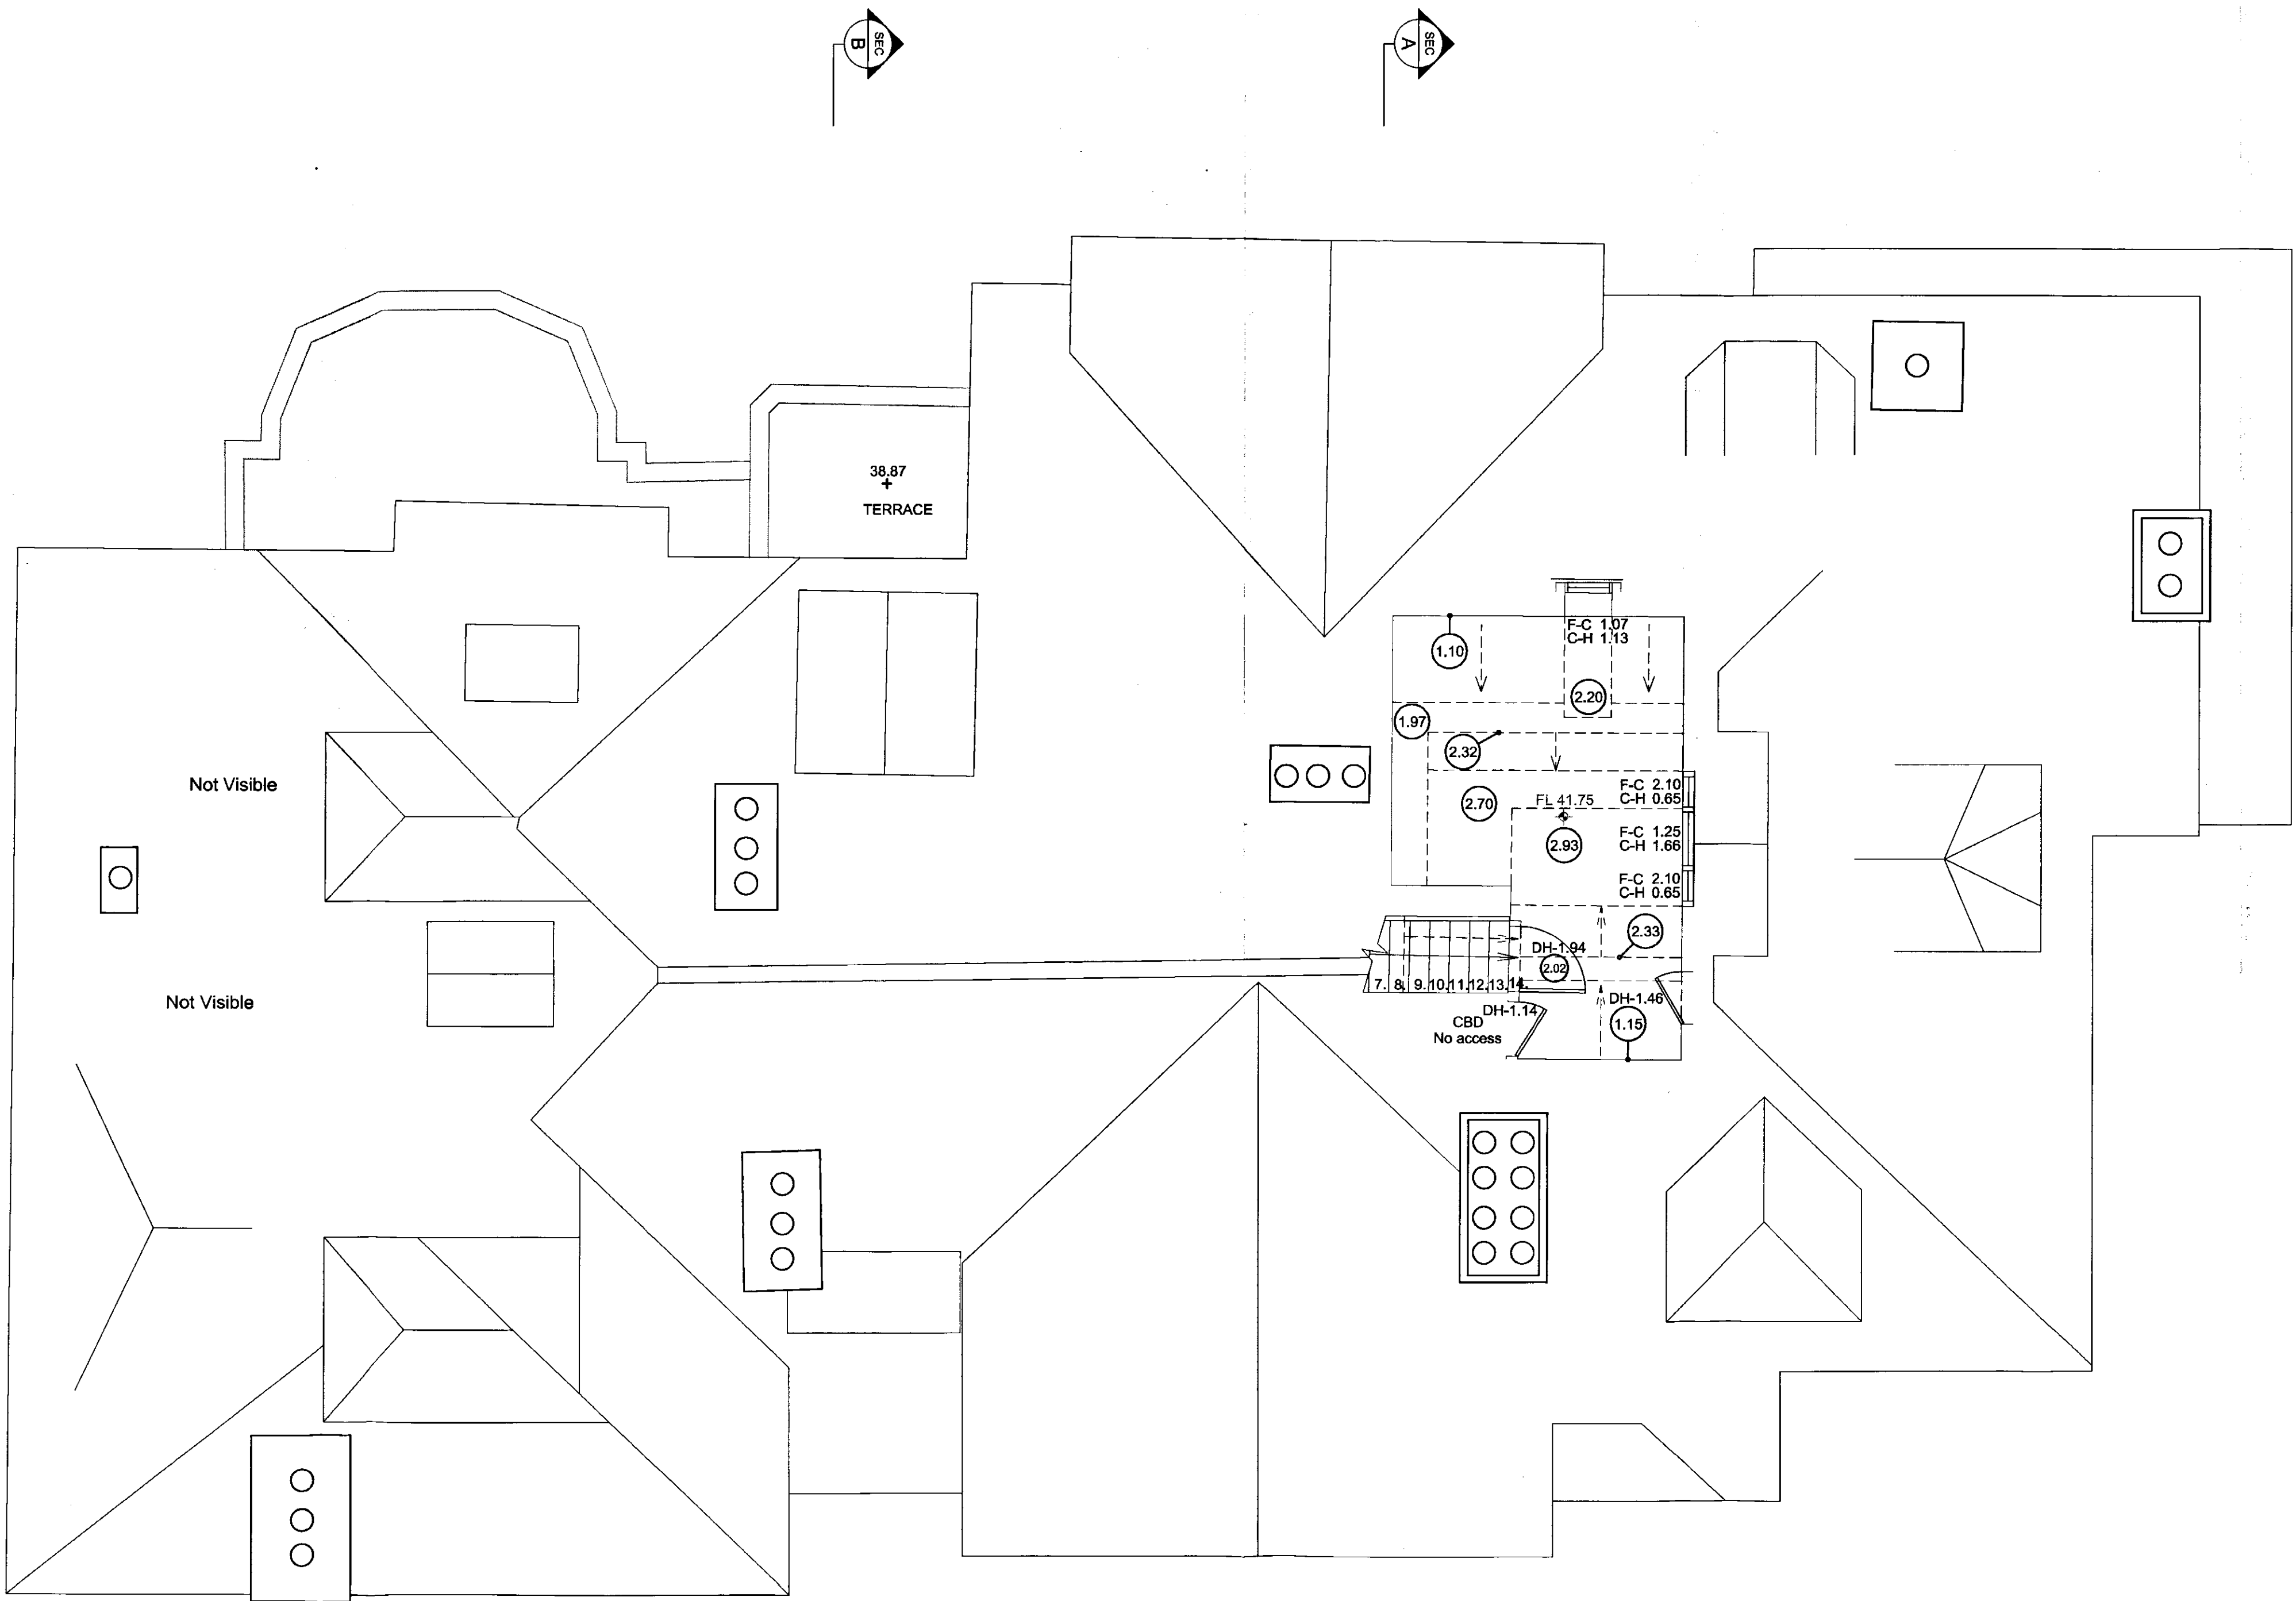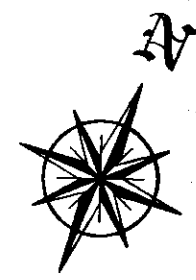

FIT MARK B

FIT MARK A

No.123 GROVE PARK
ROOF PLAN


DO NOT SCALE FROM DRAWING
ALL DIMENSIONS TO BE CHECKED ON SITE

METRO PLANS	
BUILDING SURVEY	
LEGEND	
F-C 0.00	FLOOR TO CILL HEIGHT
C-H 0.00	CILL TO HEAD HEIGHT
FL 21.80	FLOOR TO CEILING HEIGHT
FL 21.80	FLOOR LEVEL
0.00sp	SPRING HEIGHT
AS	SINGLE STEP HEIGHT
AS	ACCESS HATCH
AHL	ARCH HEAD LEVEL
BLR	BOILER
BOL	BOLLARD
BM 7	BENCHMARK
BSL	BEAM SOFFIT LEVEL
CAB	CABINET
CATV	CABLE TV
CBD	CUPBOARD
CCTV	CCTV CAMERA
CL	CEILING LEVEL
CNT	COUNTER
CH	CEILING HATCH
CL	CEILING LIGHT
CV	CEILING VENT
DH	DOOR HEIGHT
DS	DOUBLE SOCKET
EAVE/00.00	EAVE LEVEL
EW	ELECTRIC METER
EP	ELECTRICAL POLE
FC	FALSE CEILING
FP	FIRE PLACE
FB	FUSE BOARD
FA	FIRE ALARM
FI	FIRE INDICATOR
FE	FIRE EXTINGUISHER
GM	GAS METER
GP	GATE POST
GV	GAS VALVE
GY	GULLY
IC	INSPECTION CHAMBER
KI	STORM WATER INLET
LP	LAMP POST
MH	MANHOLE
-CL	COVER LEVEL
-IL	INVERT LEVEL
OHC	OVER HEAD CABLE
OHC	OVERHANG
P	POLE
PAR/00.00	PARAPET LEVEL
PAT	POST & TELECOM
PS	POWER SUPPLY
RAD	RADIATOR
RE	RODDING EYE
RS	ROAD SIGN
RWP	RAIN WATER PIPE
RIDGE/00.00	RIDGE LEVEL
SLV	SHELVING
SL	SKYLIGHT
SV	STOP VALVE
SVP	SOIL VENT PIPE
SS	SINGLE SOCKET
SW	SWITCH
ToF/00.00	TOP OF FENCE
ToW/00.00	TOP OF WALL
TP	TELEPHONE POLE
UPL	UP LIGHTER
WH	WATER HEATER
WM	WATER MAIN
WT	WATER TANK
WV	WATER VALVE
WL	WALL LAMP
(Tree Symbol)	TREE DECIDUOUS
(Tree Symbol)	TREE CONIFEROUS
(Bush Symbol)	BUSH

NOTES

All Levels to OS benchmark.
All door numbers relate to Camelot nos.

-	-	-	-
-	-	-	-
-	-	-	-
-	FULL ISSUE	07/10/2008	BB
-	PRELIMINARY	06/10/2008	BB

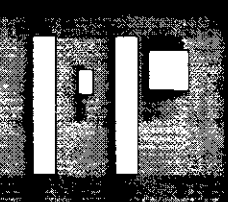

METRO PLANS
3 GALENA RD
HAMMERSMITH
LONDON W6 0LT
TEL NO. + 44 (0) 20 8741 4699
FAX NO. + 44 (0) 20 8741 6442
EMAIL: info@metroplans.com
WEB: www.metroplans.com

LAND & MEASURED BUILDING SURVEYS

SOUTHWARK COUNCIL PLANNING
CASE FILE COPY
08 APR 2011
REGISTERED NUMBER
11111111

CLIENT	CITRUS GROUP	
PROJECT	No.123 GROVE PK	
SURVEY TYPE	ROOF PLAN	
Drawn by	JG	Scale 1:50
Checked by	BB	Job No. 2538
Date	OCT 2008	Dwg No. 2538-05